

# **AGENDA ITEM 6**

## **APPENDIX I**


**2020/0119/DET**

**PLANS**







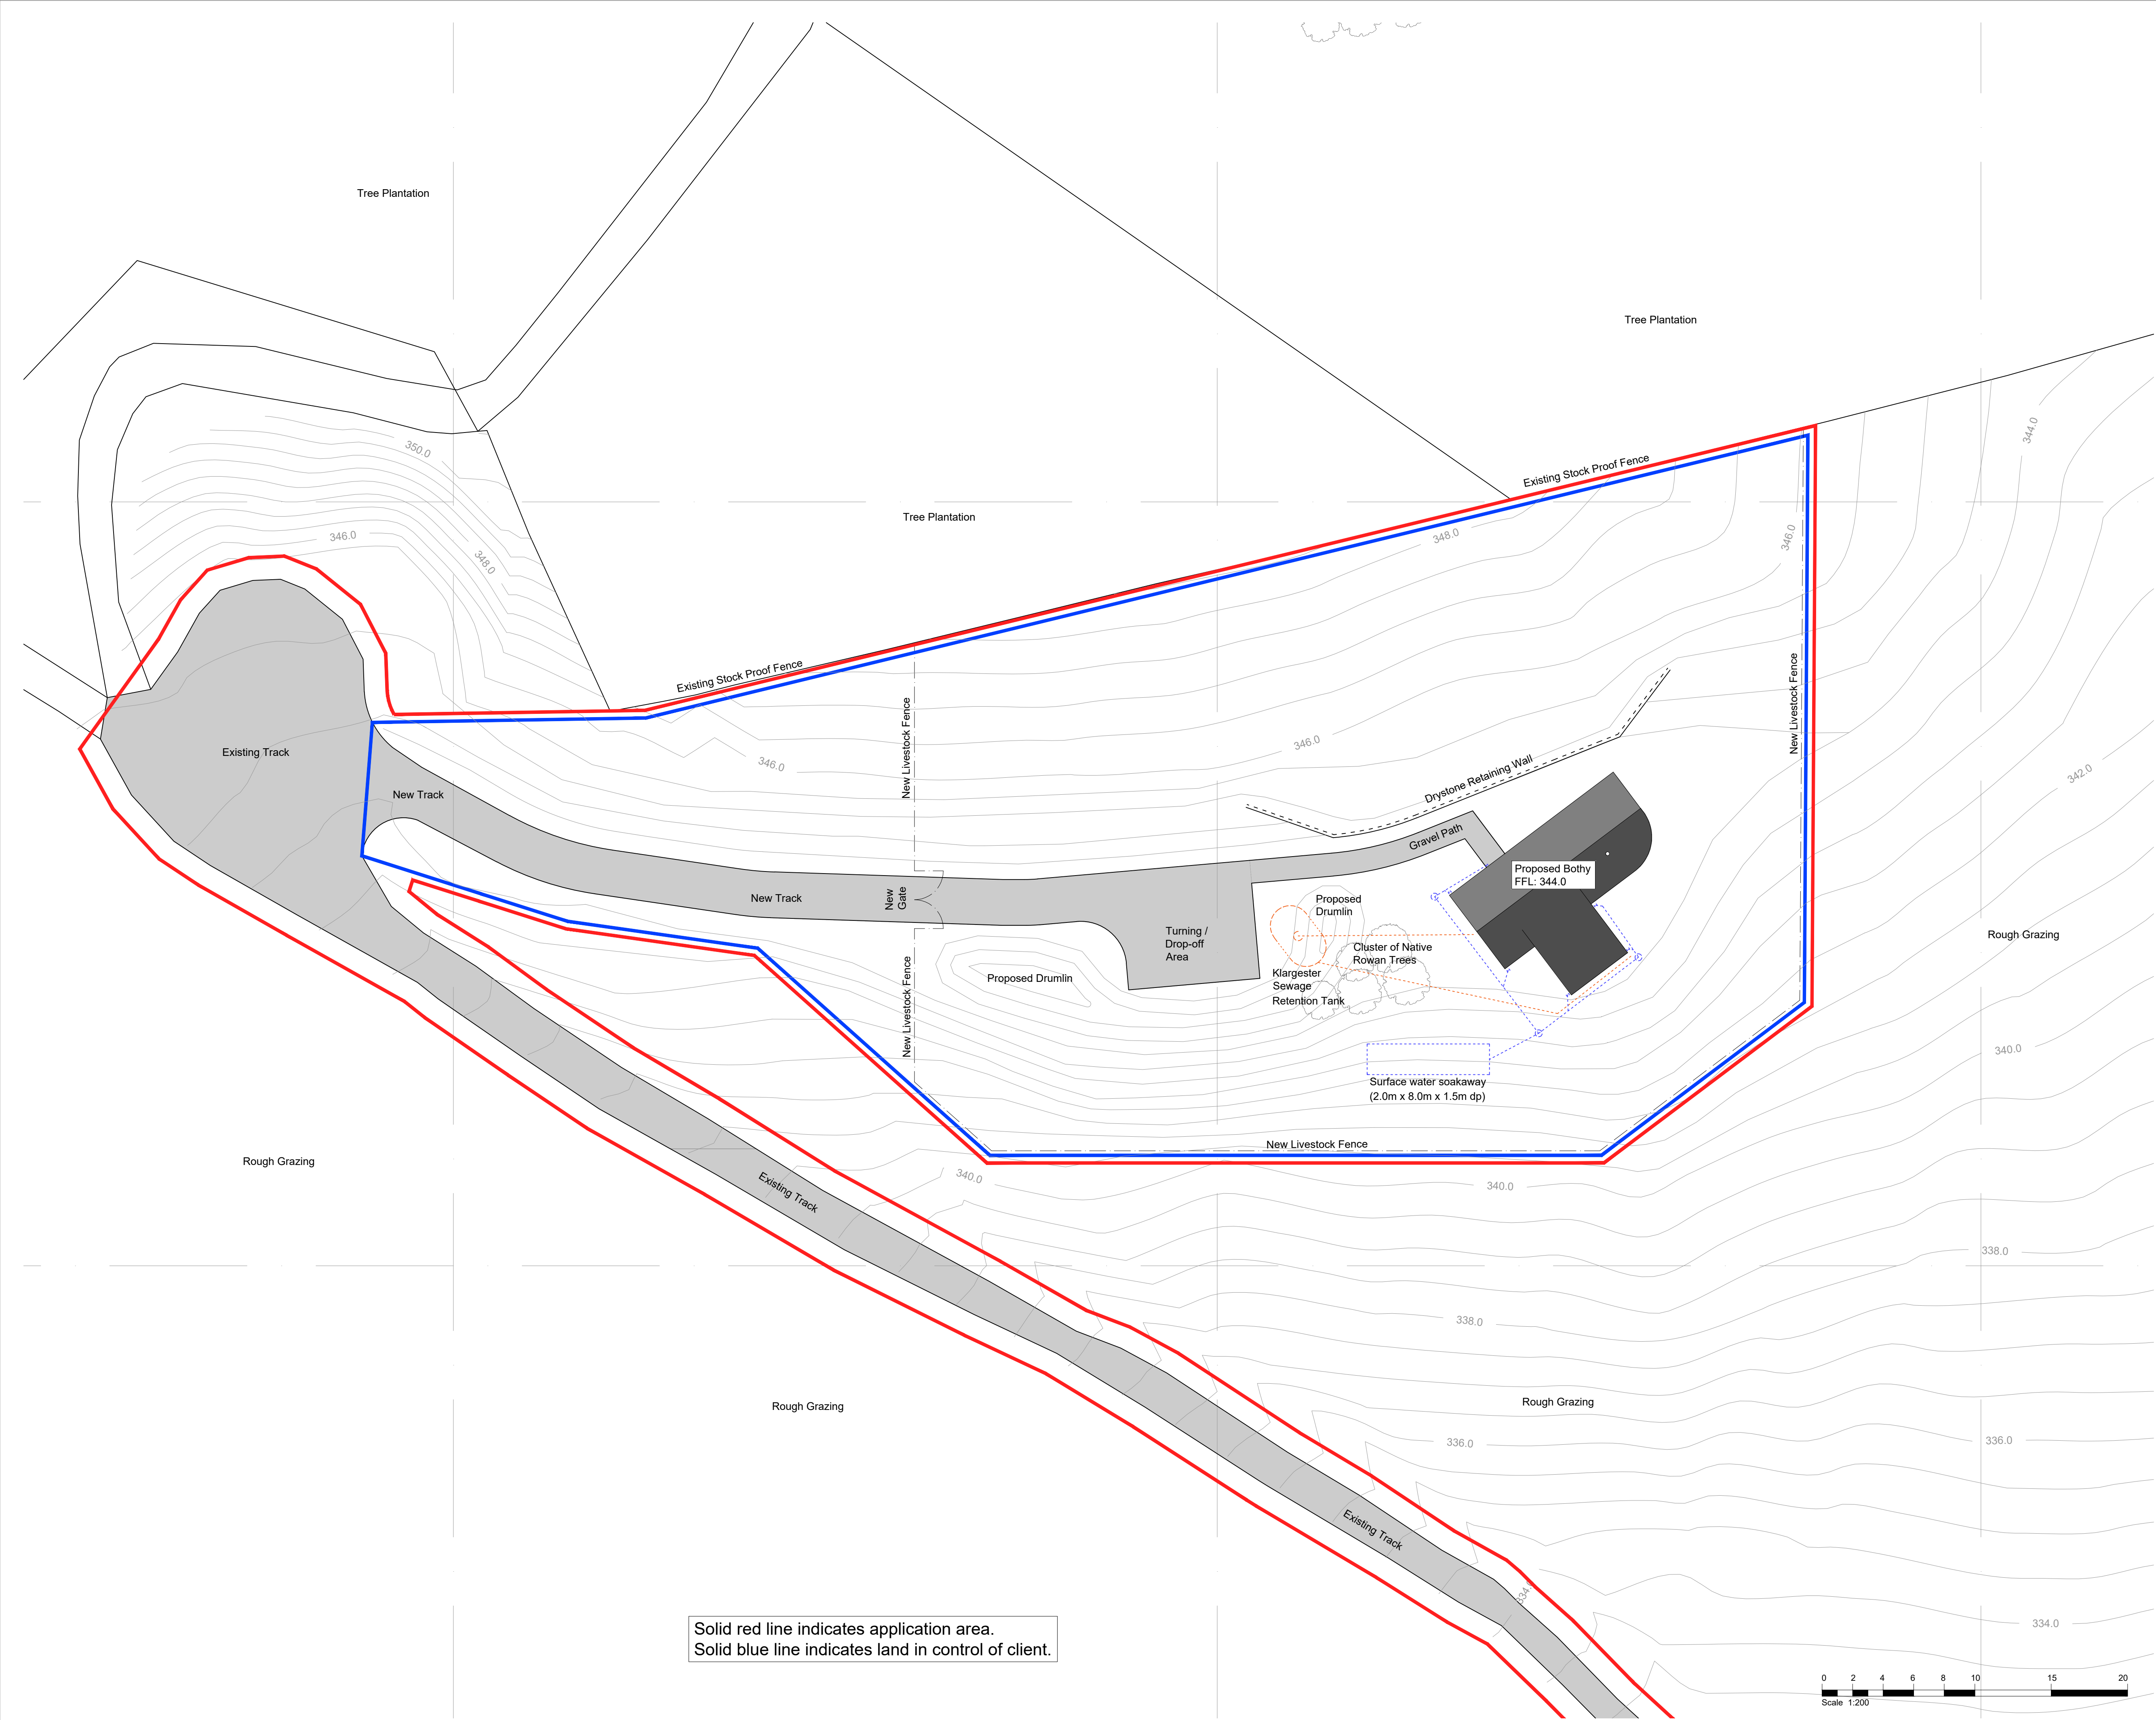

DATE	REVISION	REV	DRW	CHK
02/04/2020	Updated following design changes.	A	RM	MF
15/06/2020	Drainage updates.	B	RM	MF

This drawing has been prepared solely for the use of:  
**Chivas Brothers Ltd.**  
and there are no representations of any kind made by  
NORR Consultants Limited to any party with whom NORR  
Consultants Limited has not entered into a contract.

This drawing must not be used, reproduced or revised  
without written permission.

This drawing shall not be used for construction purposes  
until the "CONSTRUCTION" status appears under the  
Sheet Status.

Constructors must only work to figured dimensions which  
are to be checked on site. Do not scale from hard copy  
drawings.

Keyplan

North Arrow


Detail Symbol

Consultants


**NORR**  
NORR Consultants Limited.  
An Ingenium International Company

5 Longman Road  
Inverness IV1 1RY  
Scotland, UK  
norr.com

Drawn	RM	Date	23/01/2020
Checked	MF	Date	23/01/2020
Scale	1:200 @ A1		
Client	Chivas Brothers Ltd.		
Project	The Glenlivet Tasting Lodge		
Drawing Title	Site Plan		
Sheet Status	PLANNING		
Project No.	IAIV18-0015		
Drawing No.	A102		Rev. B

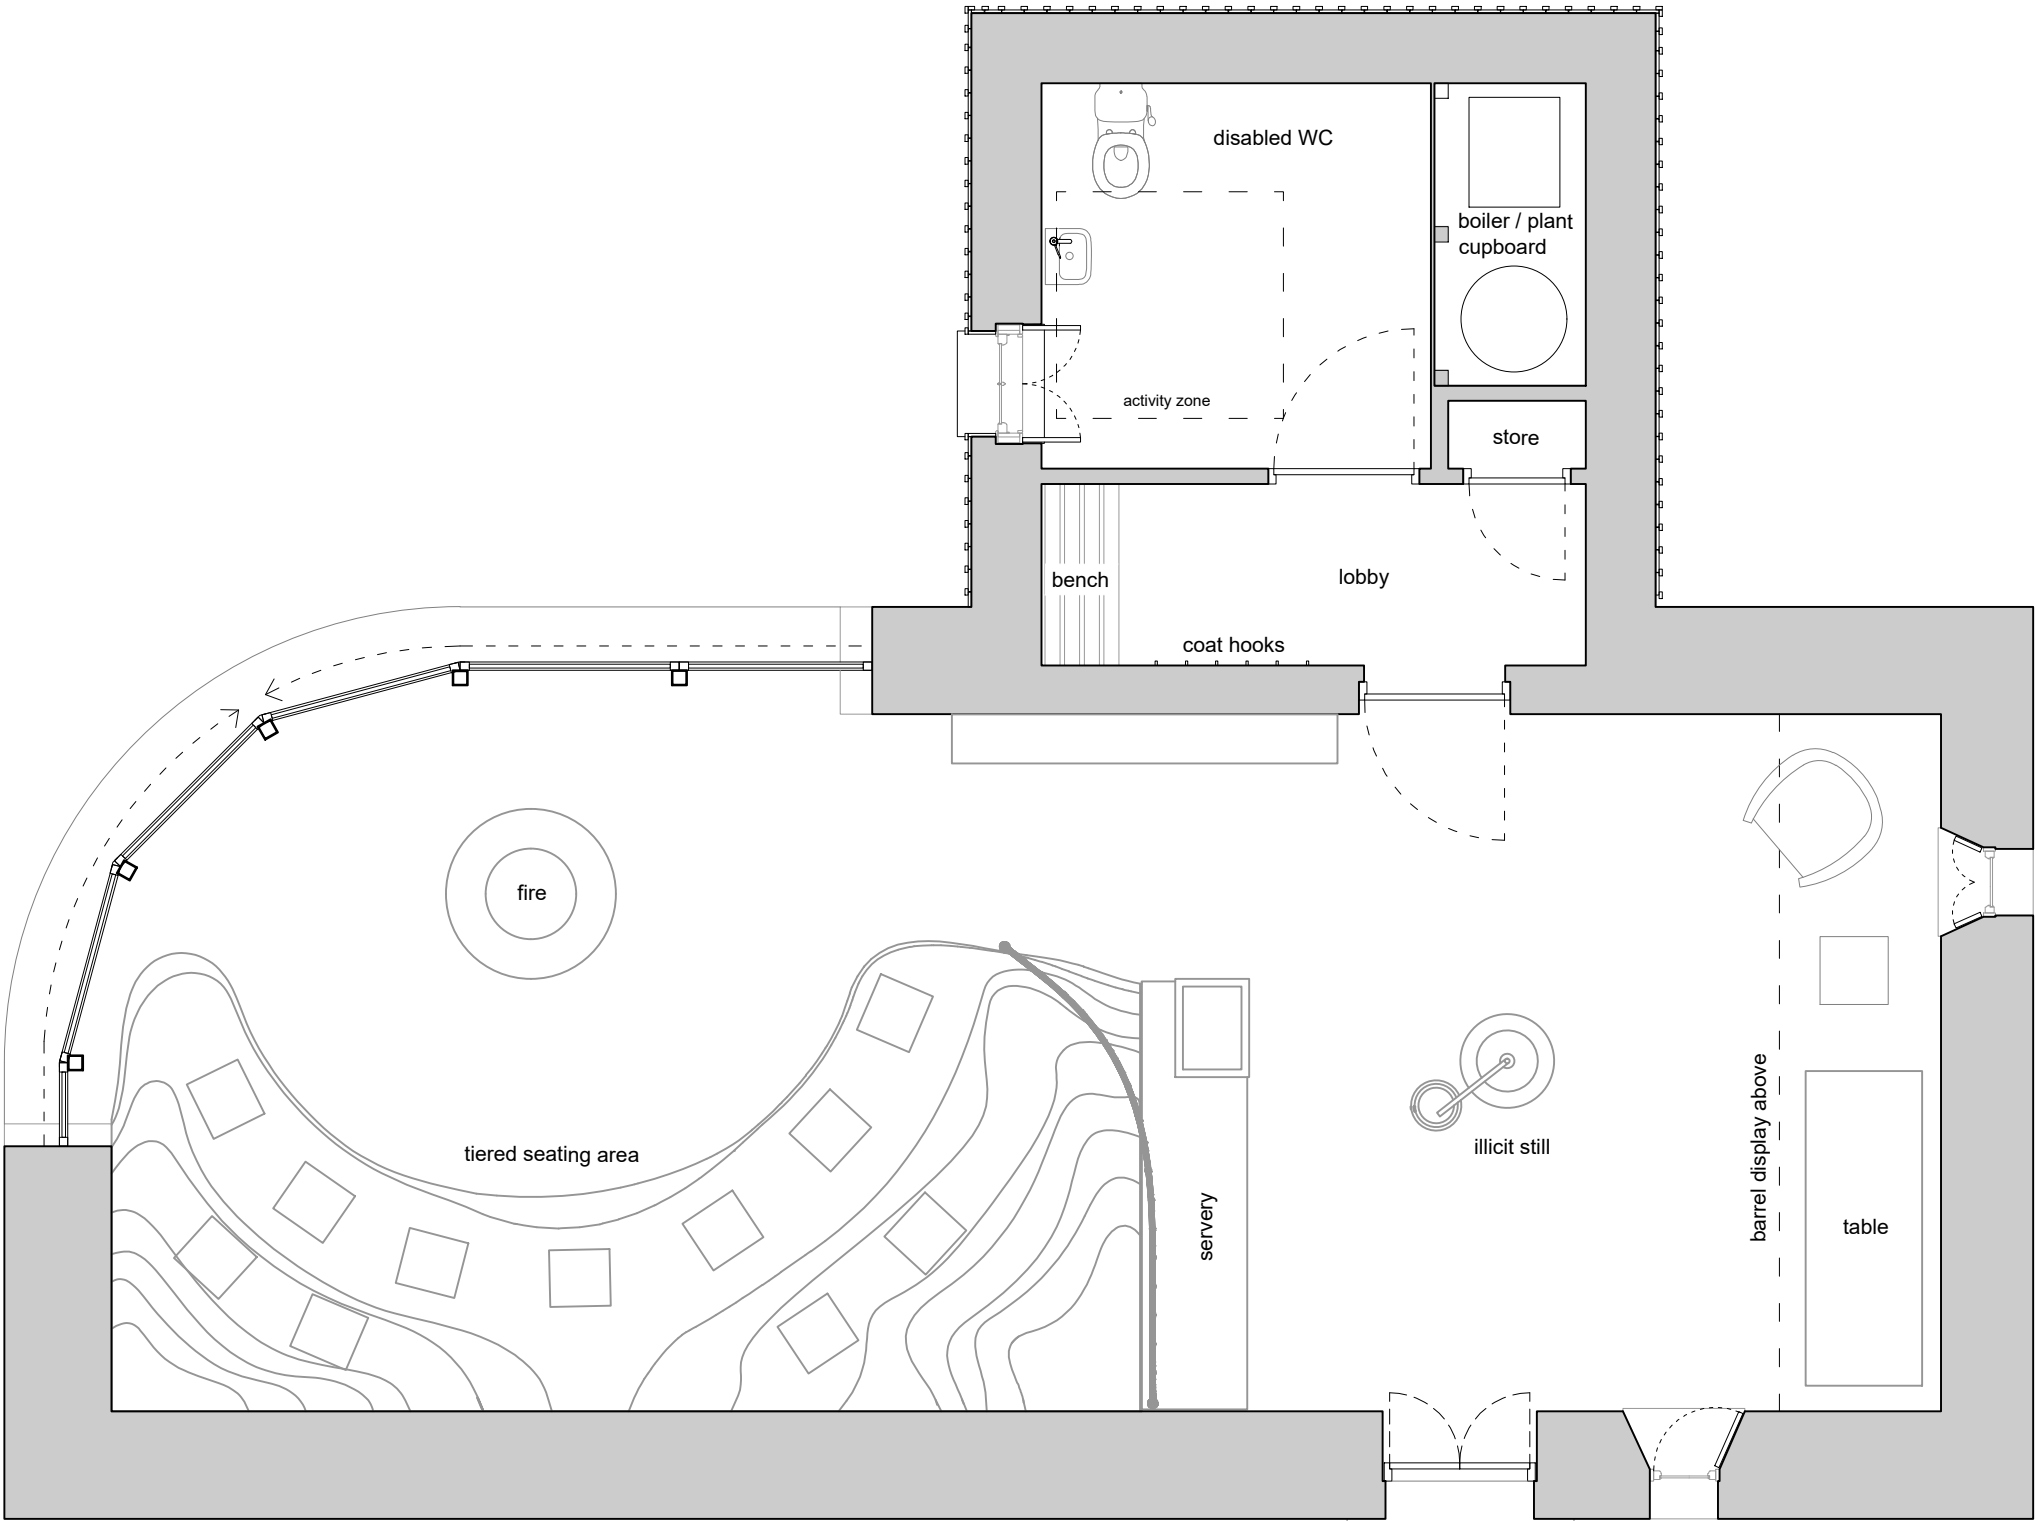


Proposed Plan - Scale 1:50

 

DATE	REVISION	REV	DRW	CHK																		
02/04/2020	Updated following design changes.	A	RM	MF																		
<div></div> <p>This drawing has been prepared solely for the use of <b>Chivas Brothers Ltd.</b> and there are no representations of any kind made by NORR Consultants Limited to any party with whom NORR Consultants Limited has not entered into a contract</p> <p>This drawing must not be used, reproduced or revised without written permission.</p> <p>This drawing shall not be used for construction purposes until the "CONSTRUCTION" status appears under the Sheet Status.</p> <p>Constructors must only work to figured dimensions which are to be checked on site. Do not scale from hard copy drawings</p> <div><b>NORR</b> NORR Consultants Limited. An Ingenium International Company</div> <p>5 Longman Road Inverness IV1 1RY Scotland, UK norr.com</p> <table><tr><td>Drawn</td><td>Date</td></tr><tr><td>RM</td><td>01/04/2020</td></tr><tr><td>Checked</td><td>Date</td></tr><tr><td>MF</td><td>01/04/2020</td></tr></table> <p>Project Name</p> <p>The Glenlivet Tasting Lodge</p> <p>Drawing Title</p> <p>Proposed Plan</p> <table><tr><td>Scale</td><td>1:50 @ A3</td></tr><tr><td>Sheet Status</td><td>PLANNING</td></tr><tr><td>Project No.</td><td>IAIV18-0015</td></tr><tr><td>Drawing No.</td><td>A101</td></tr><tr><td>Rev.</td><td>A</td></tr></table>					Drawn	Date	RM	01/04/2020	Checked	Date	MF	01/04/2020	Scale	1:50 @ A3	Sheet Status	PLANNING	Project No.	IAIV18-0015	Drawing No.	A101	Rev.	A
Drawn	Date																					
RM	01/04/2020																					
Checked	Date																					
MF	01/04/2020																					
Scale	1:50 @ A3																					
Sheet Status	PLANNING																					
Project No.	IAIV18-0015																					
Drawing No.	A101																					
Rev.	A																					



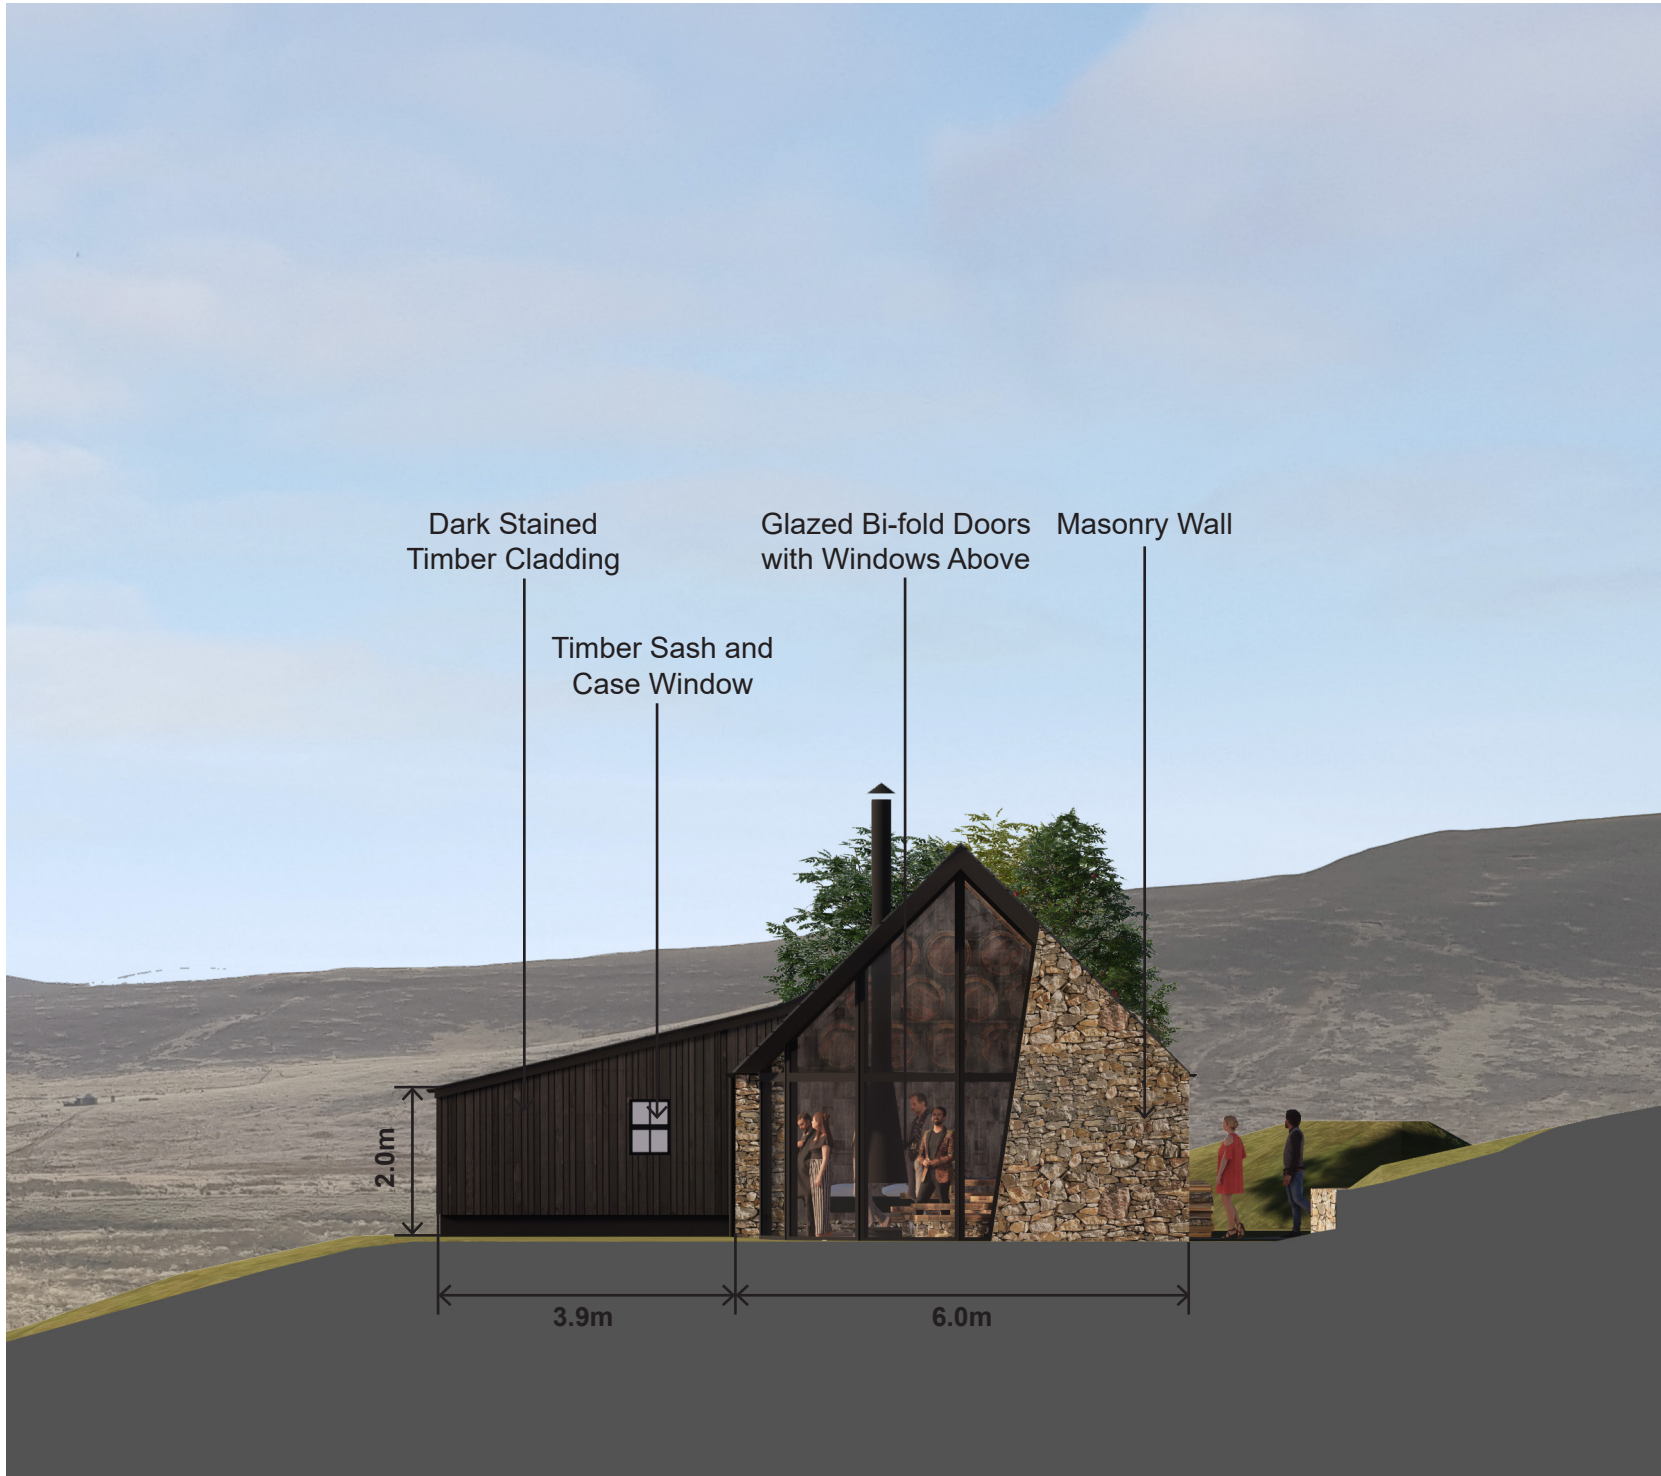


North Elevation - Scale 1:100




East Elevation - Scale 1:100



South Elevation - Scale 1:100

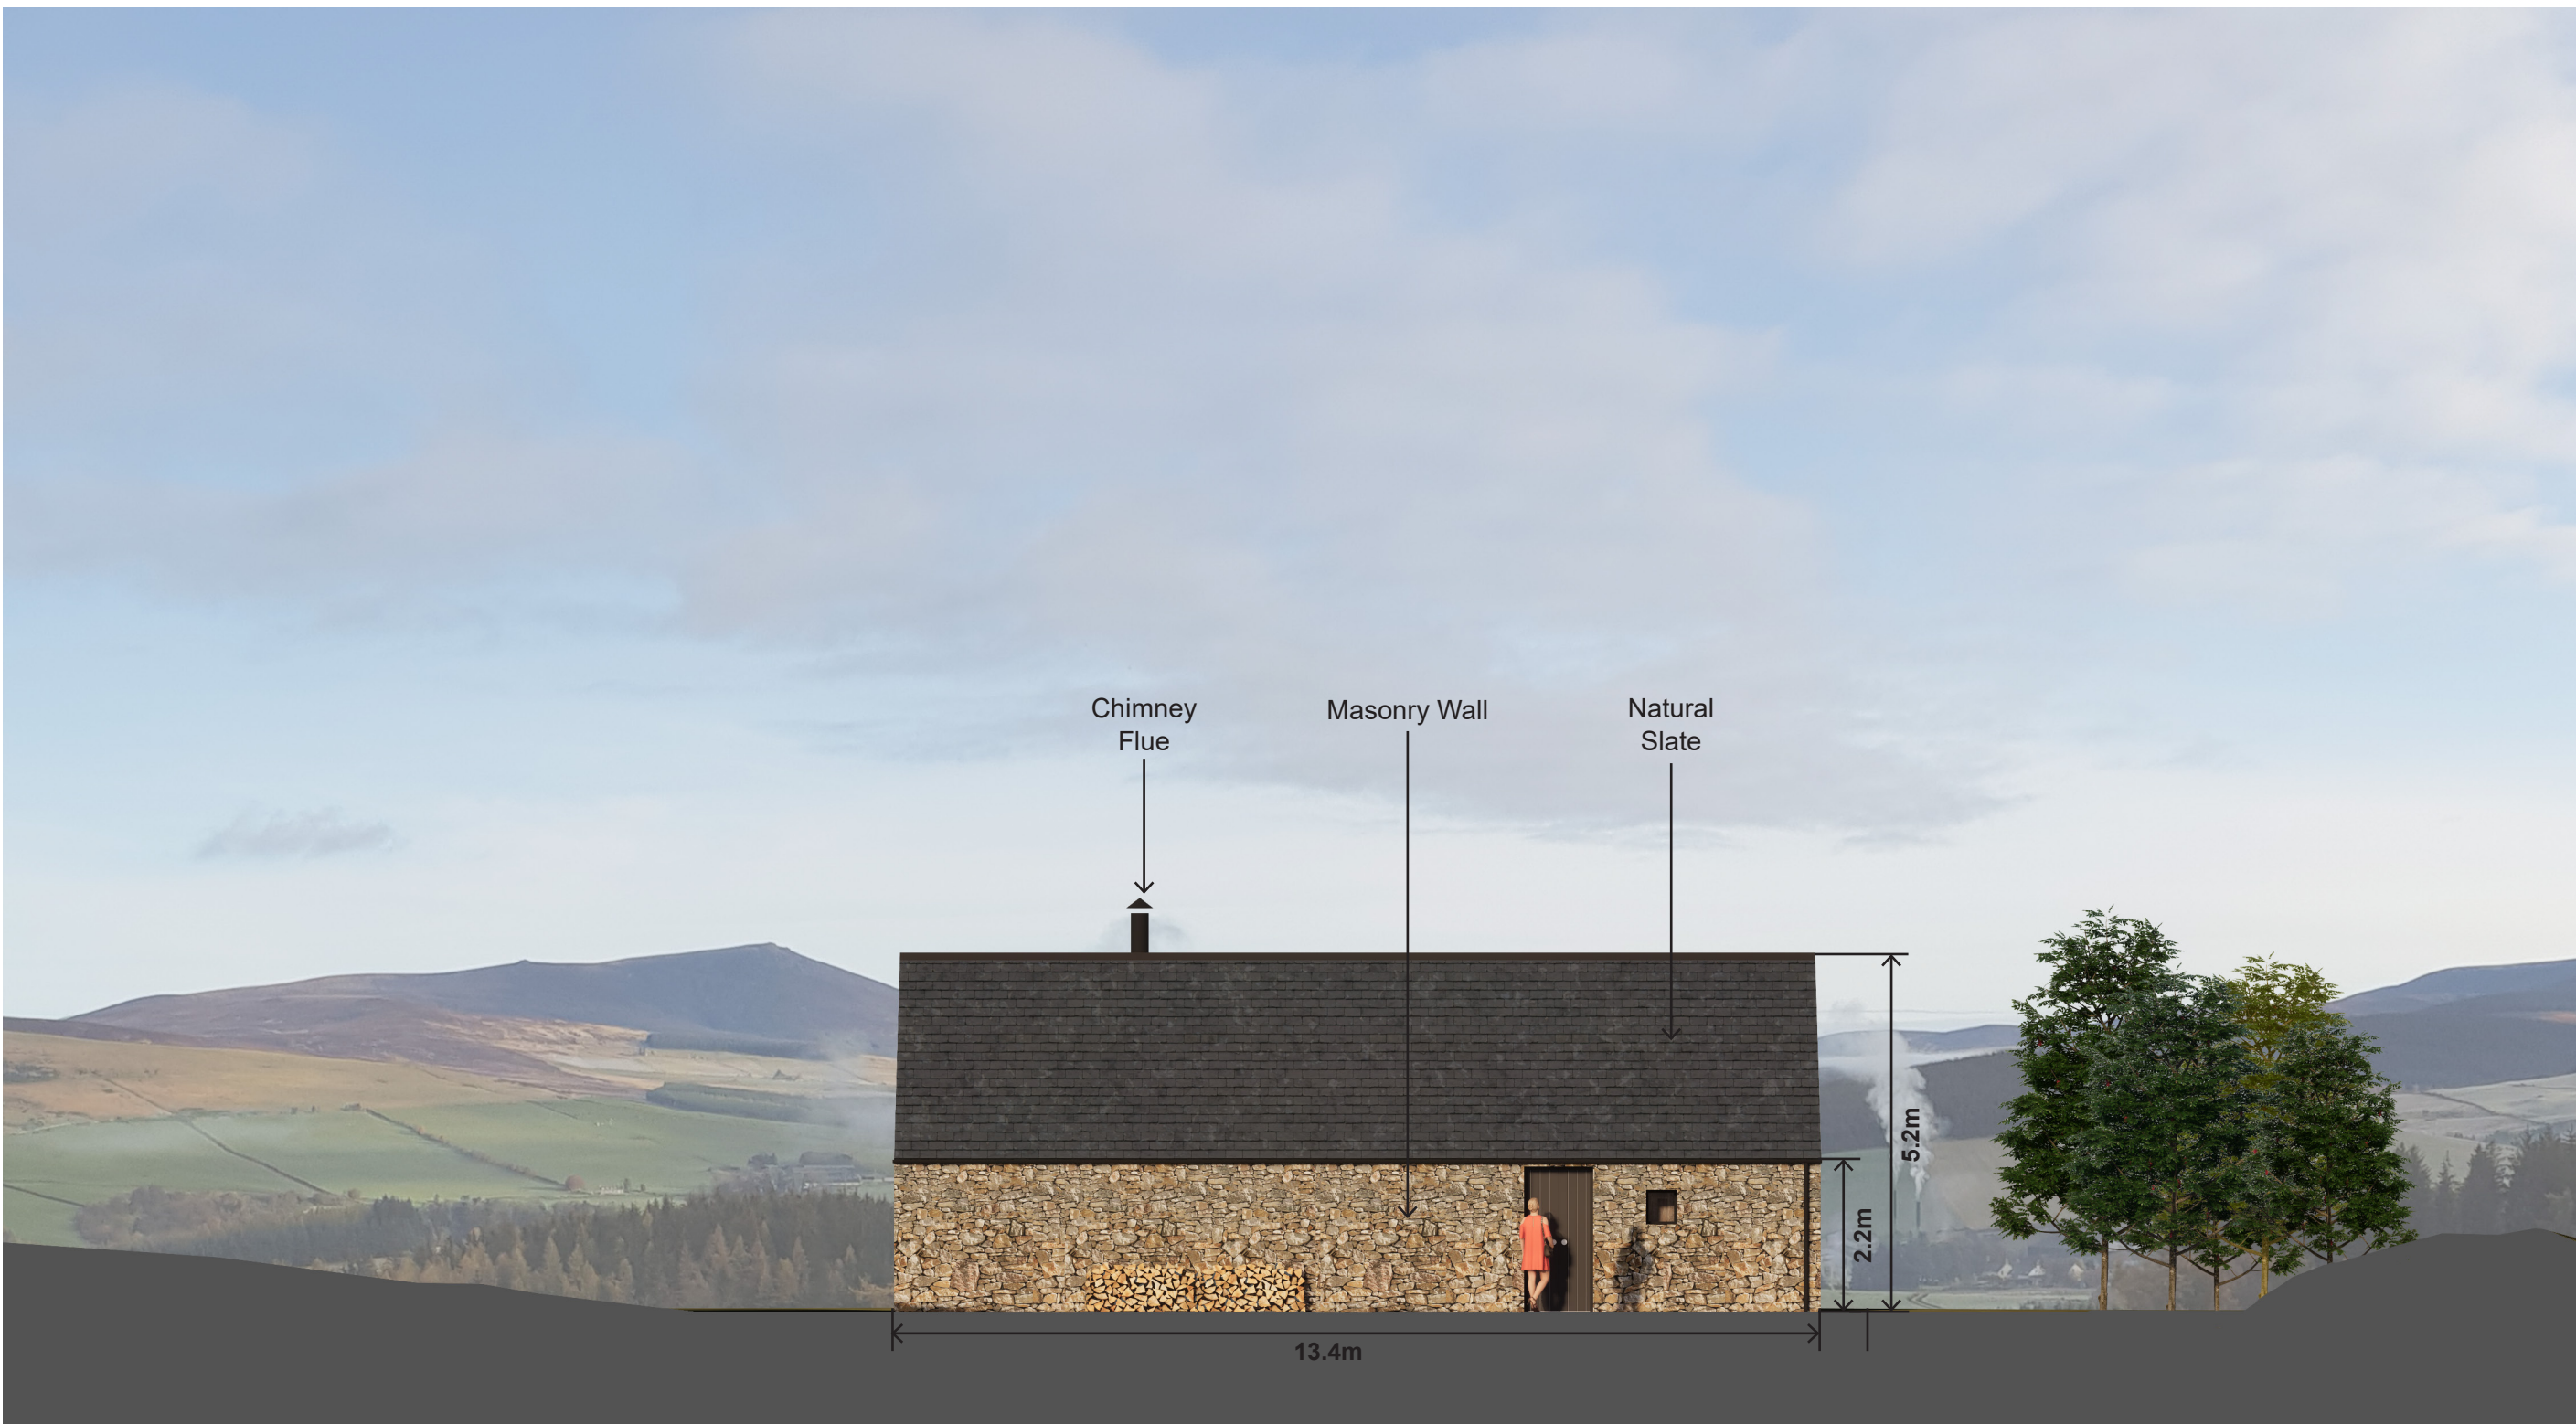

West Elevation - Scale 1:100

 

DATE	REVISION	REV	DRW	CHK
27/01/20	Notes added highlighting proposed materials.	A	RM	MF
02/04/20	Updated to reflect design changes.	B	RM	MF

This drawing has been prepared solely for the use of:  
**Chivas Brothers Ltd.**  
and there are no representations of any kind made by  
NORR Consultants Limited to any party with whom NORR  
Consultants Limited has not entered into a contract.

This drawing must not be used, reproduced or revised  
without written permission.

This drawing shall not be used for construction purposes  
until the "CONSTRUCTION" status appears under the  
Sheet Status.

Constructors must only work to figured dimensions which  
are to be checked on site. Do not scale from hard copy  
drawings.

Keyplan

North Arrow

Detail Symbol

Consultants

**NORR**  
NORR Consultants Limited.  
An Ingenium International Company

5 Longman Road  
Inverness IV1 1RY  
Scotland, UK  
norr.com


Drawn	RM	Date	23/01/2020
Checked	MF	Date	23/01/2020
Scale	1:100	@	A1
Client	Chivas Brothers Ltd.		
Project	The Glenlivet Tasting Lodge		
Drawing Title	Proposed Elevations		
Sheet Status	PLANNING		
Project No.	IAIV18-0015		
Drawing No.	A100		Rev. B





Luminaire Schedule		
Ref	Description	Control Method
A1	LIOUS POULSEN or EQUAL, 9.5 WATT 900 LUMENS WALL MOUNTED LED LUMINAIRE (FULLY SHIELDED)	SWITCH ON/OFF DIMMER or PIR
B	LINEAR LED TAPE 3.72 W/m 487 LUMENS IN ALUMINIUM HOUSING TO LIGHT CEILING	SWITCH ON/OFF DIMMER
C	CEILING or RECESSED MOUNTED LED DOWNLIGHTERS 9 WATT 800 LUMENS (FULLY SHIELDED)	PIR
D	9.5 WATT 900 LUMENS LED ZUMTOBEL PENDANT or EQUAL OVER PREPERATION AREA (FULLY SHIELDED)	SWITCH ON/OFF
E1	3 WATT SELF-CONTAINED NON-MAINTAINED EMERGENCY LIGHT, SURFACE/RECESSED MOUNTED INTERNALLY ABOVE DOOR	PIR/LUX SMART CONTROL INTEGRAL BATTERY FOR EMERGENCY LIGHT PURPOSES
F	15 WATT WALL MOUNTED SURFACE LED LIGHT FITTING. ASA CENTRO CIRCC	SWITCH ON/OFF

Legend	
Symbol	Description
	9 WAY SP+N MCB/RCBO DISRRIBUTION BOARD & SWITCH/DIMMER MODULES TO CONTROL LIGHTING

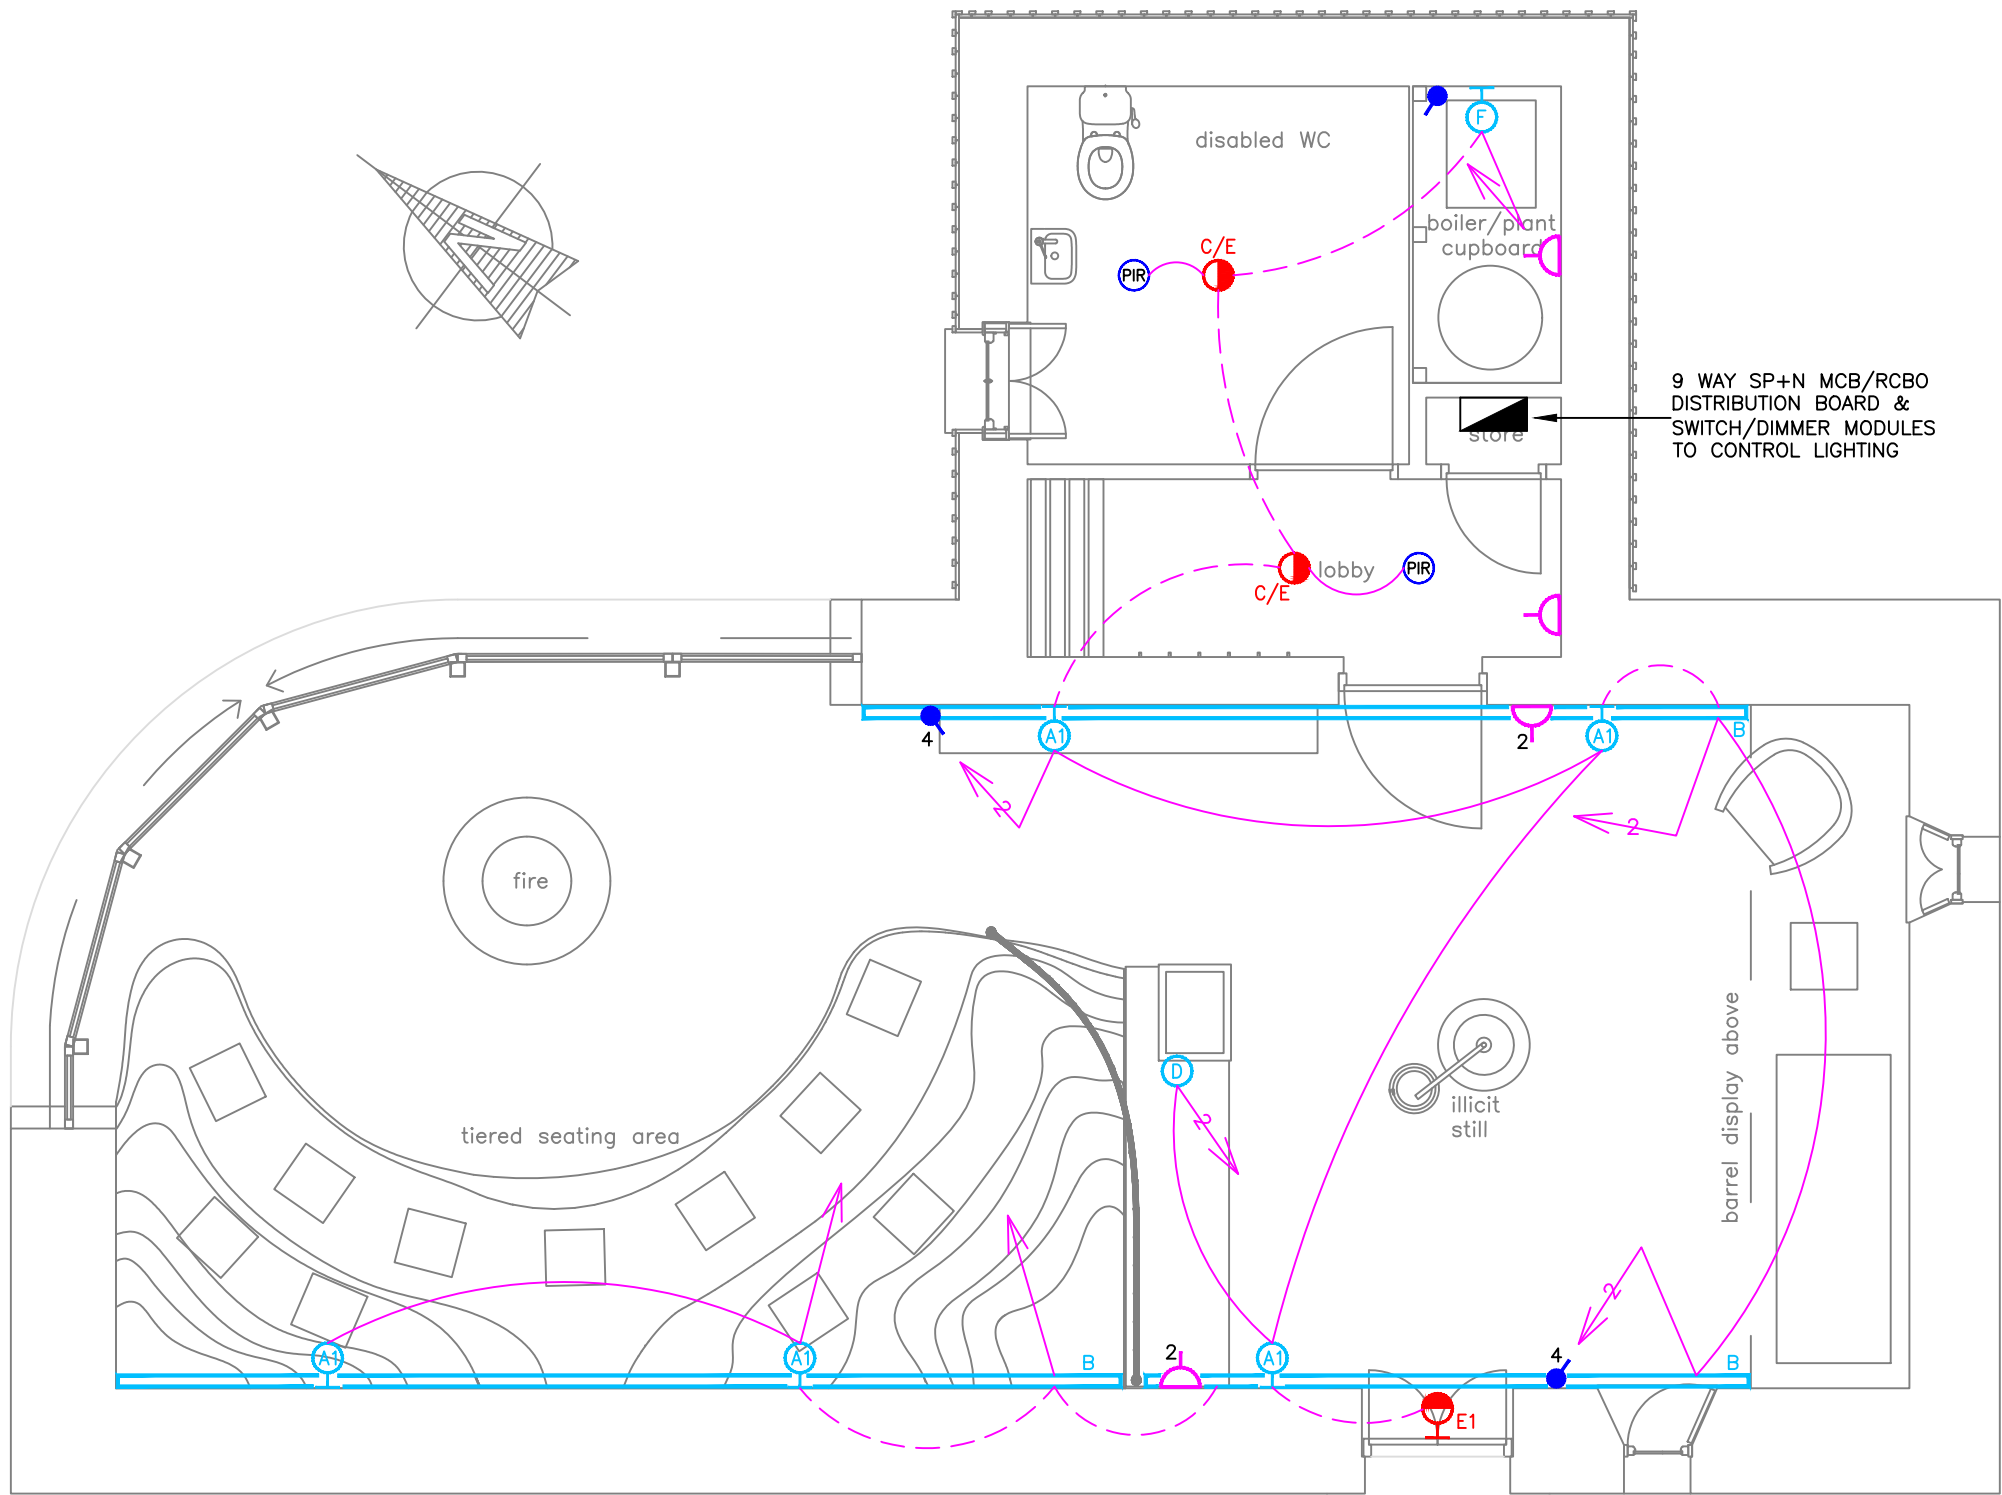

Revisions	Date	Dm.	Revisions	Date	Dm.	Revisions	Date	Dm.


PLANNING  
DRAWING

CLIENT CHIVAS BROTHERS Ltd		
PROJECT THE GLENLIVET BOTHY		
LIGHTING & SMALL POWER LAYOUT		
Drawn: G.R.	Ck'd: J.K.	Scale: 1:50 @ A3
Date: Dec.'19	Date: Dec.'19	DO NOT SCALE


**BLYTH&BLYTH**  
Cornerstone, 60 South Gyle Crescent  
Edinburgh EH12 9EB  
Email: edinburgh@blythandblyth.co.uk  
www.blythandblyth.co.uk  
Telephone: 0131 474 2700

Drawing No.  
**EM22320:63:001**


Revision

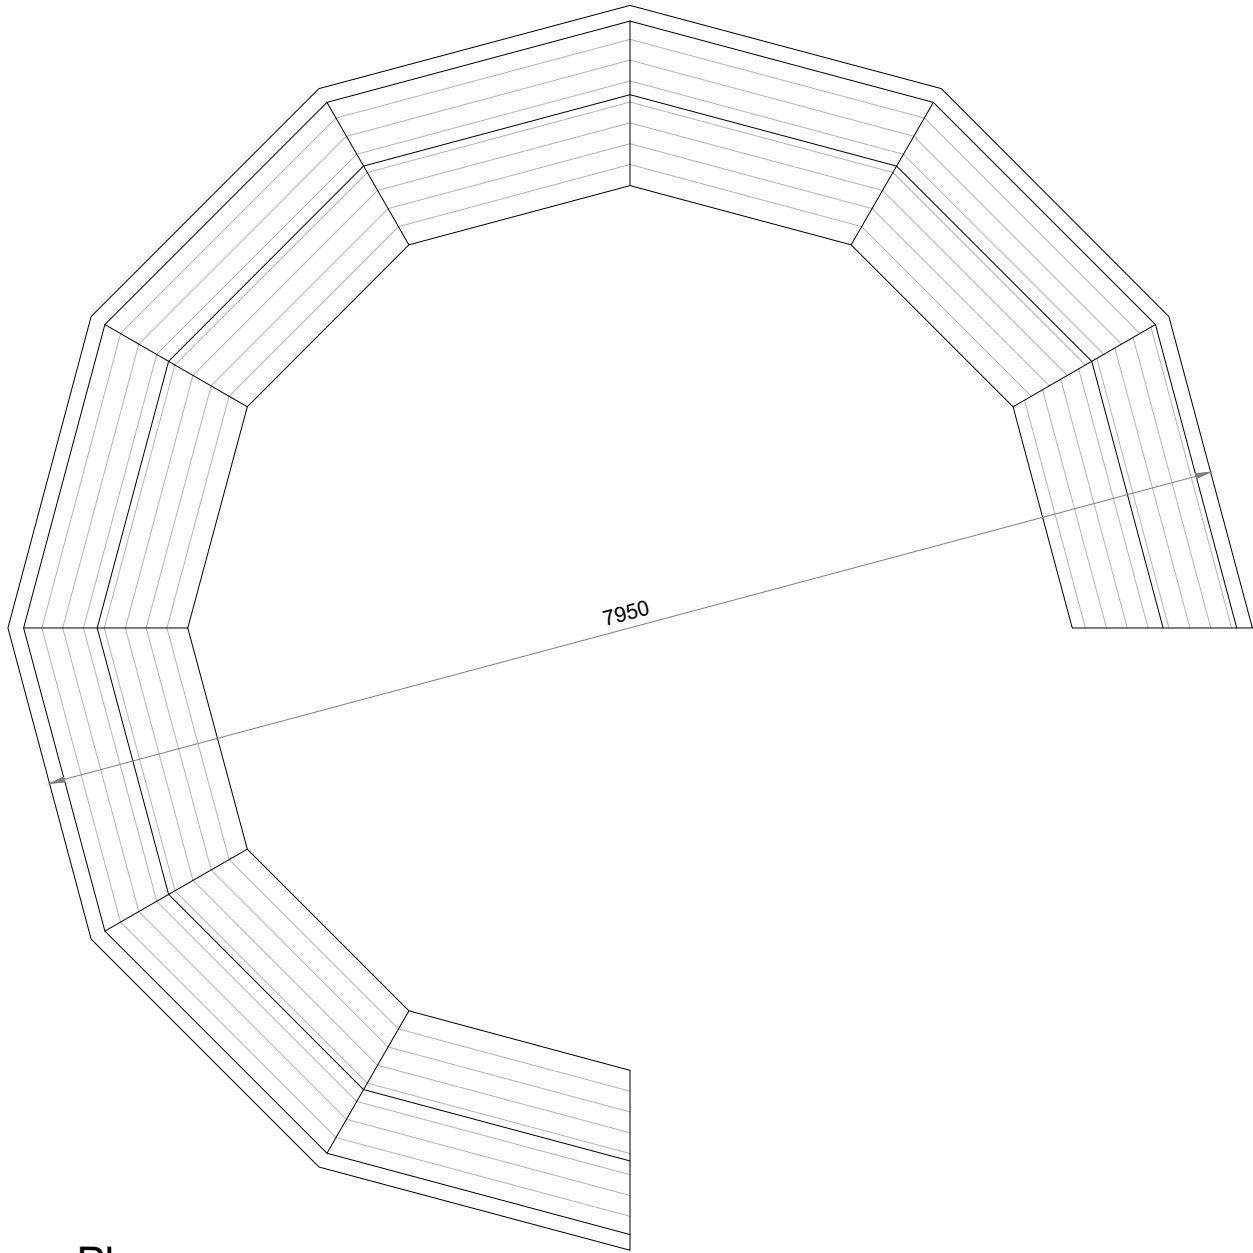


Plan

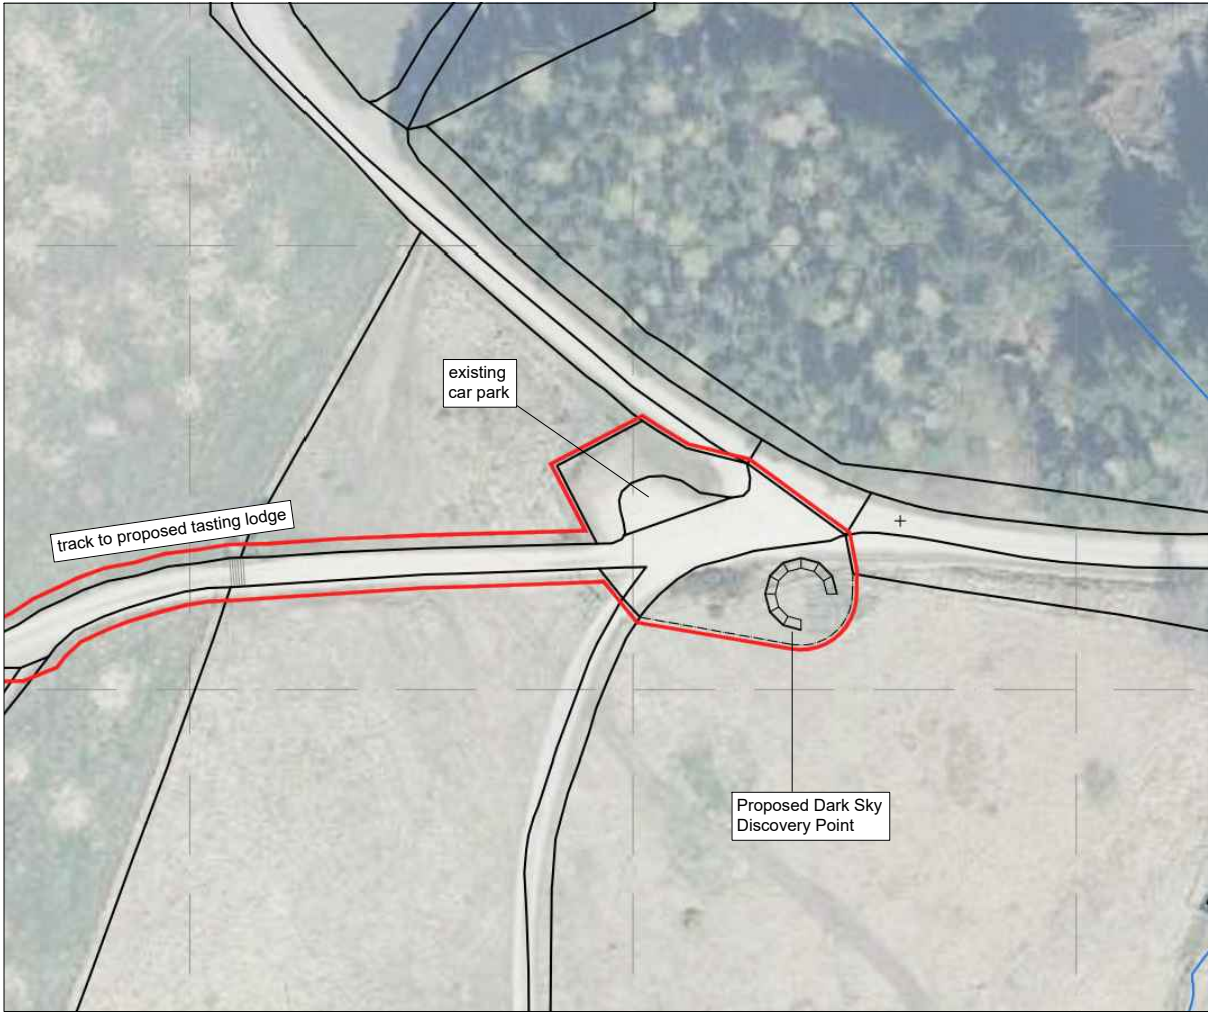

Dark Sky Discovery Point Context - NTS

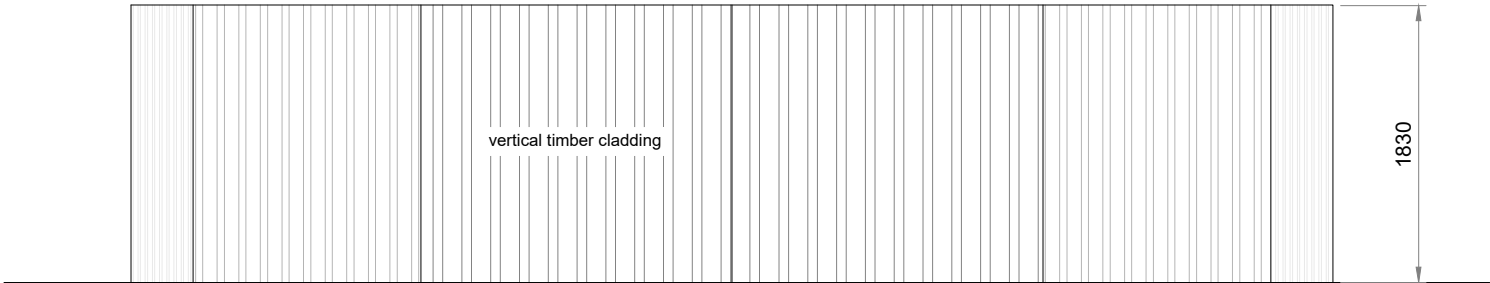


Elevation

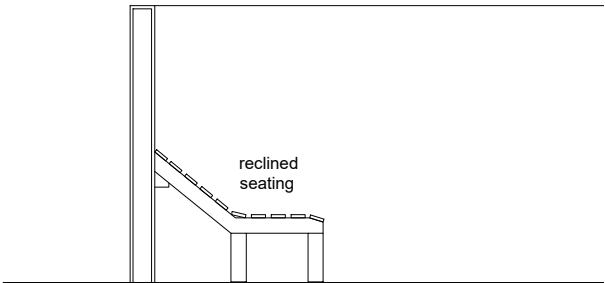

Section

DATE	REVISION	REV	DRW	CHK
31/08/2020	First Issue	P01	RM	MF

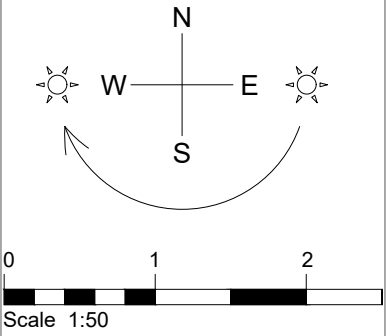

This drawing has been prepared solely for the use of Chivas Brothers Ltd. and there are no representations of any kind made by NORR Consultants Limited to any party with whom NORR Consultants Limited has not entered into a contract.

This drawing must not be used, reproduced or revised without written permission.

This drawing shall not be used for construction purposes until the "CONSTRUCTION" status appears under the Sheet Status.

Constructors must only work to figured dimensions which are to be checked on site. Do not scale from hard copy drawings

**NORR**  
NORR Consultants Limited.  
An Ingenium International Company

5 Longman Road  
Inverness IV1 1RY  
Scotland, UK  
norr.com

Drawn RM	Date 31/08/20
Checked MF	Date 31/08/20

Project Name  
The Glenlivet Tasting Lodge

Drawing Title  
Dark Sky Discovery Point  
Plan, Elevation, Section

Scale 1:50 @ A3	Sheet Status
Project No. IAIV18-0015	
Drawing No. TGL-NOR-TL-00-DR-A-00090	Rev. P01